

# VALLEY CREEK CORPORATE CENTER

Exton, PA  
a development of



4100 One Commerce Square  
2005 Market Street



## Wallace Roberts & Todd, LLC


260 South Broad Street Philadelphia, PA 19102 215.732.5215 fax 215.732.2551

Contractors  
Mechanical, Electrical, & Plumbing Engineering

McHugh Engineering  
550 Pinetown Road, Suite 205  
Fort Washington, PA 19034  
Phone: 215-641-1155 Fax: 215-641-0194


Structural Engineering  
Cagley, Harman & Associates  
1015 West North Avenue  
King of Prussia, PA 19406  
Phone: 610-337-3380 Fax: 610-337-3359

Specifications  
FOCUS Collaborative, Inc.  
1285 Stage Coach Road  
Parsippany, NJ 08054  
Phone: 609-390-8281 Fax: 609-390-7504

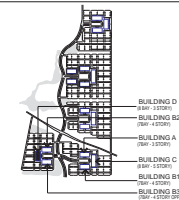

6/27/14

## PHASE I BUILDING I BUILDING TYPE D

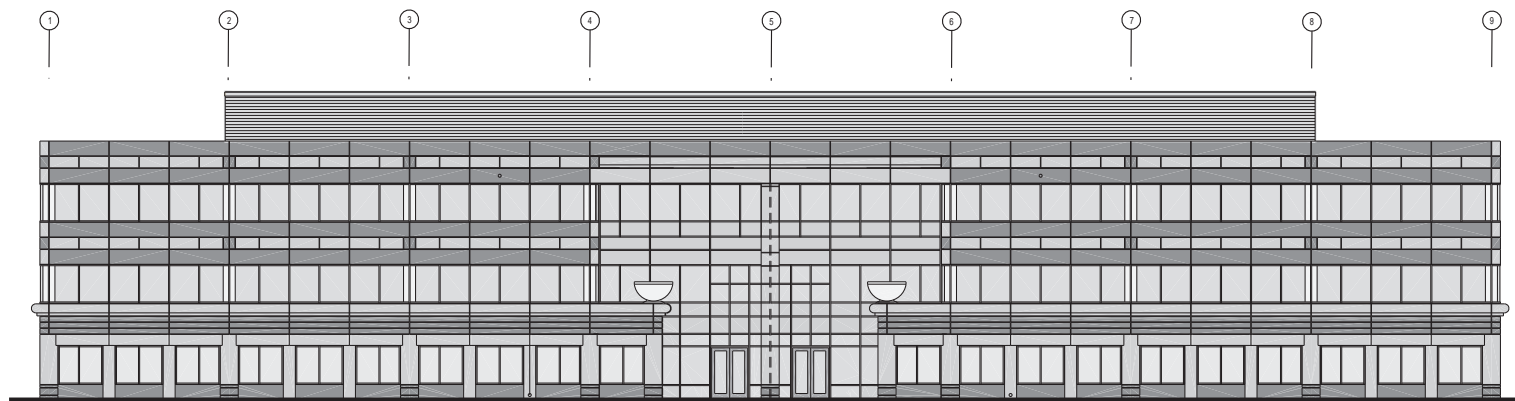

EAST & WEST ELEVATION



SOUTH ELEVATION

NORTH ELEVATION

Drawing Title:  
ELEVATIONS

Drawing No.: