

VALLEY CREEK CORPORATE CENTER


Exton, PA
a development of




WRT Planning & Design

Wallace Roberts & Todd, LLC
260 South Broad Street Philadelphia, PA 19102
215.732.5215 fax 215.732.2551

Consultants:
Mechanical, Electrical, & Plumbing Engineering
McHugh Engineering
550 Pineshen Road, Suite 205
Fort Washington, PA 19034
Phone: 215-641-1158 Fax: 215-641-0194
Structural Engineering
Cagley, Harman & Associates
1015 West North Avenue
King of Prussia, PA 19406
Phone: 610-337-3360 Fax: 610-337-3359
Specifications
FOCUS Collaborative, Inc.
1290 Stage Coach Road
Palermo, NJ 08230
Phone: 609-390-8281 Fax: 609-390-7504

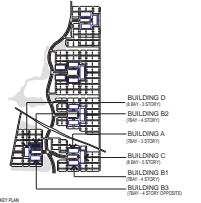

PHASE I BUILDING II BUILDING TYPE B2

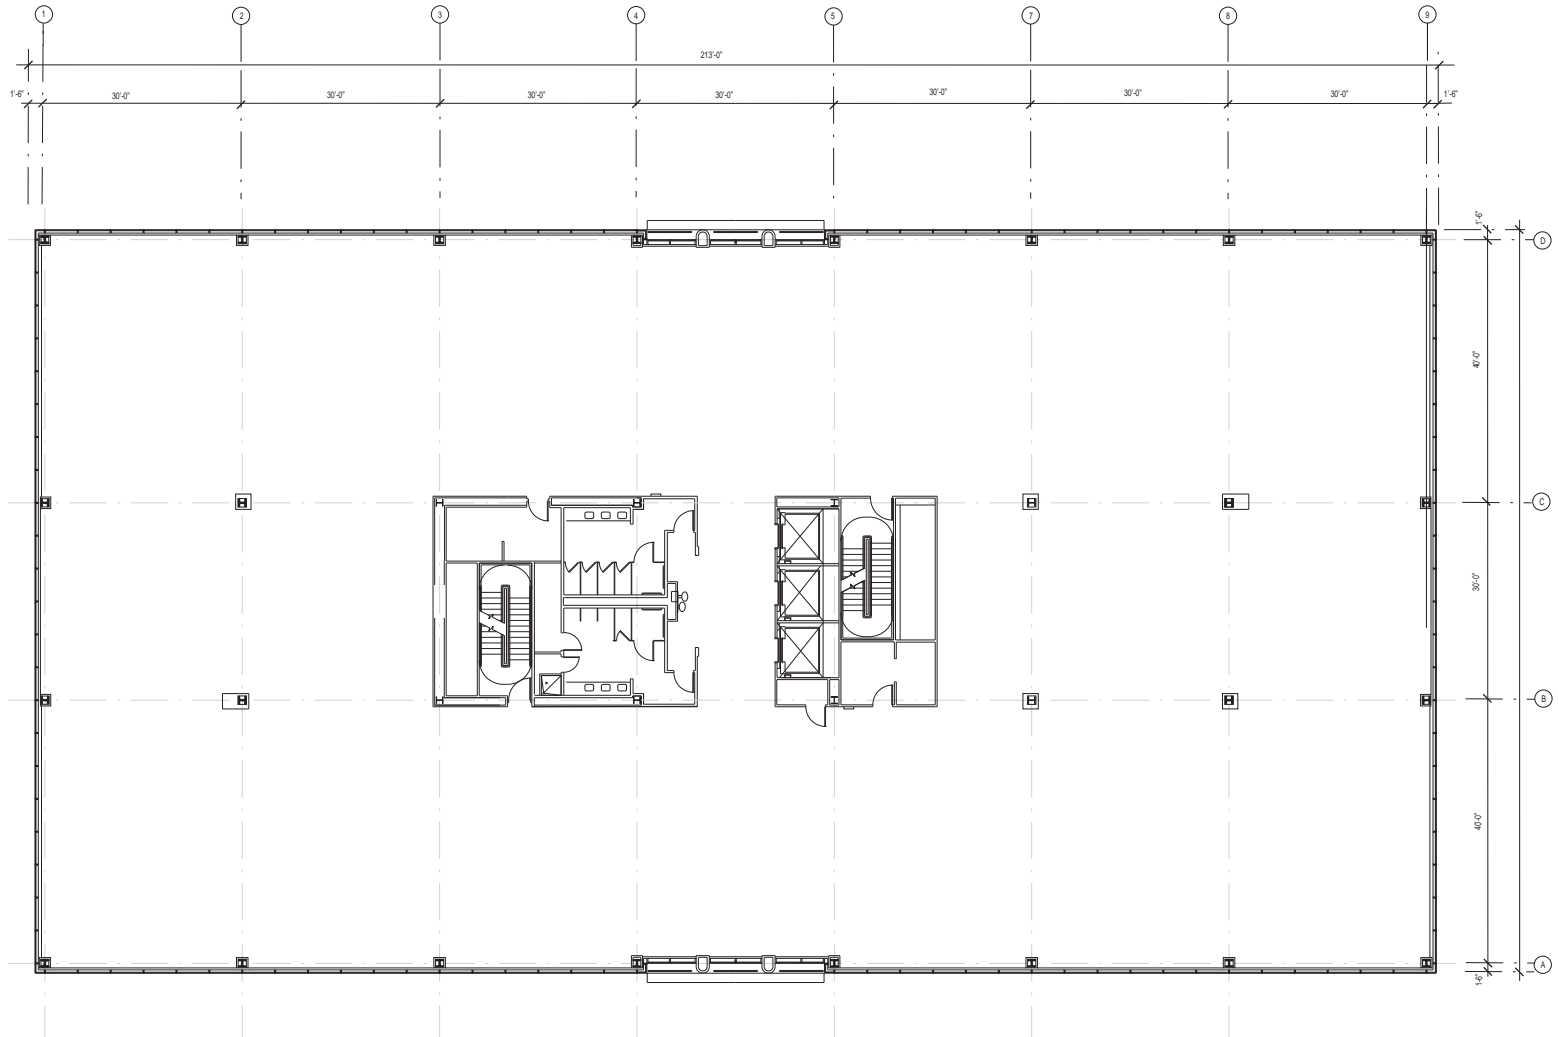

THIRD FLOOR PLAN

Drawing Title:	THIRD FLOOR PLAN
Drawing No:	