

VALLEY CREEK CORPORATE CENTER

Exton, PA
a development of




4100 One Commerce Square
2005 Market Street



Wallace Roberts & Todd, LLC
260 South Broad Street Philadelphia, PA 19102
215.732.5215 fax 215.732.2551


- Consultants:
- Mechanical, Electrical, & Plumbing Engineering
McHugh Engineering
550 Pines Hill Road, Suite 205
Fort Washington, PA 19334
Phone: 215-641-1158 Fax: 215-641-0194
 - Structural Engineering
Cagle, Harman & Associates
1015 West North Avenue
King of Prussia, PA 19406
Phone: 610-337-3360 Fax: 610-337-3359
 - Specifications
FOCUS Collaborative, Inc.
1290 Stage Coach Road
Palermo, NJ 08230
Phone: 609-390-8281 Fax: 609-390-7504

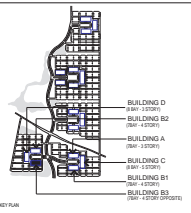

PHASE I BUILDING III BUILDING TYPE B3

Drawing Title:
**FOURTH FLOOR
PLAN**

Drawing No:

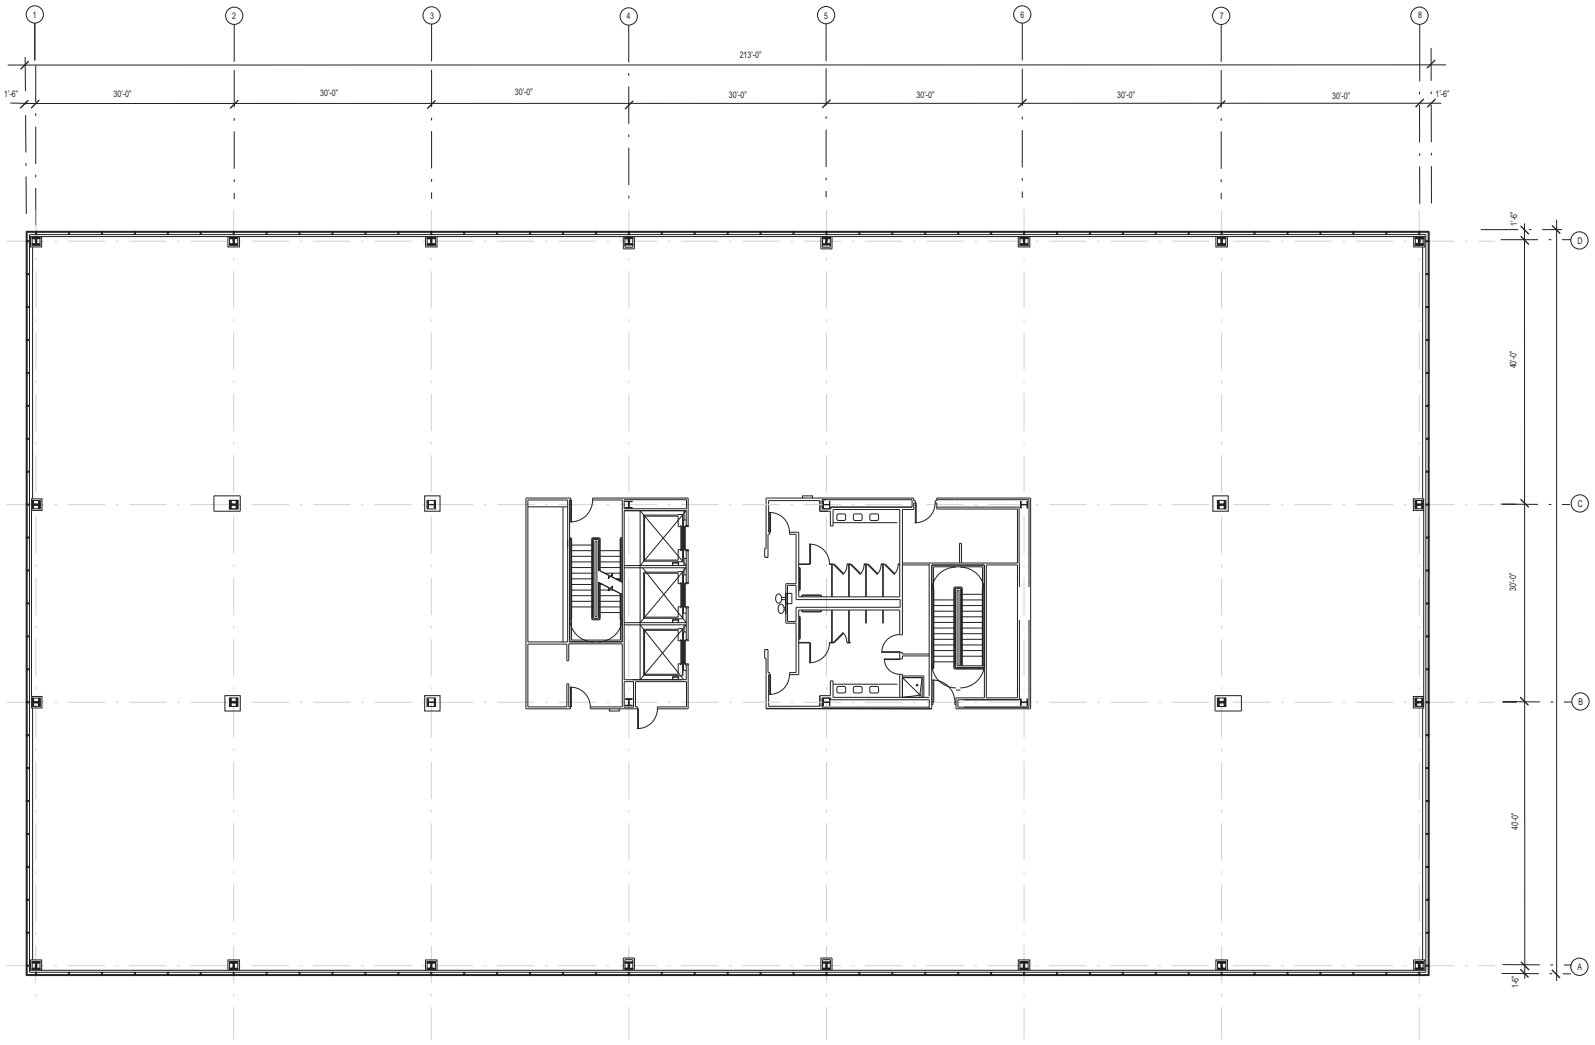

FOURTH FLOOR PLAN