

VALLEY CREEK CORPORATE CENTER

Exton, PA
a development of



4100 One Commerce Square
2005 Market Street




Wallace Roberts & Todd, LLC
260 South Broad Street Philadelphia, PA 19102 215.732.5215 fax 215.732.2551


Consultants
Mechanical, Electrical, & Plumbing Engineering
McHugh Engineering
550 Pineshire Road, Suite 205
Fort Washington, PA 19034
Phone: 215-641-1158 Fax: 215-641-0194

Structural Engineering
Cagley, Harman & Associates
1015 West North Avenue
King of Prussia, PA 19405
Phone: 610-337-3360 Fax: 610-337-3359


Specifications
FOCUS Collaborative, Inc.
1290 Stage Coach Road
Palermo, NJ 08230
Phone: 609-390-8281 Fax: 609-390-7504

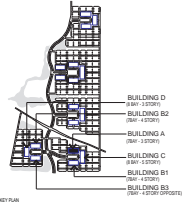


PHASE II BUILDING I BUILDING TYPE A

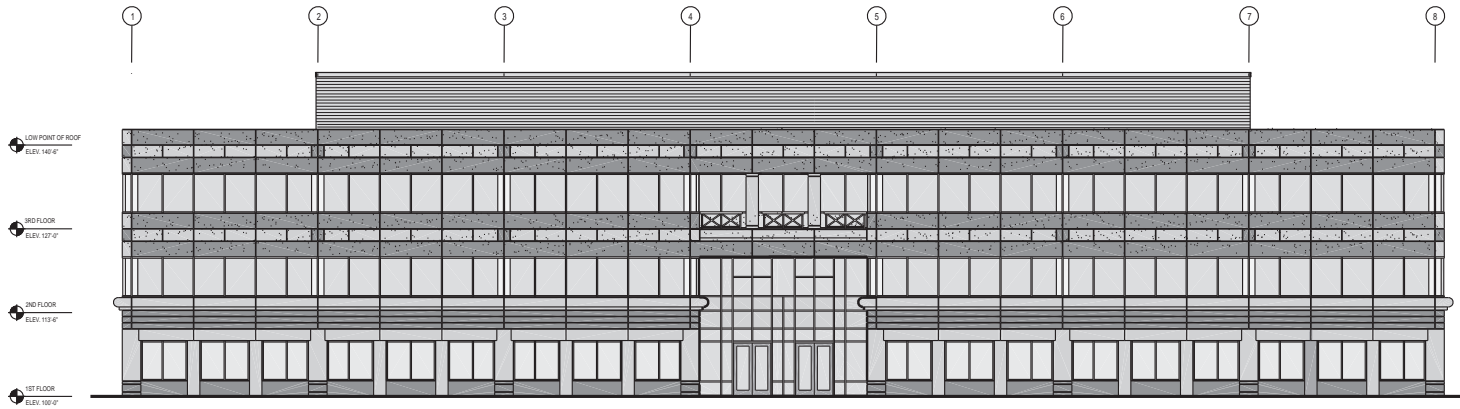

NORTH & SOUTH ELEVATION

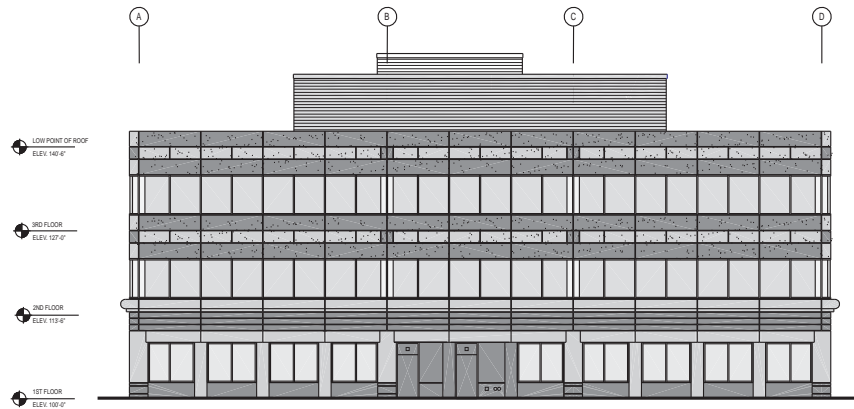

EAST ELEVATION

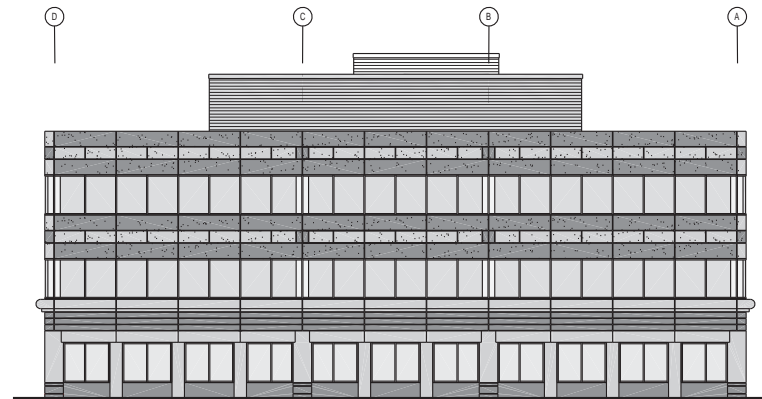

WEST ELEVATION

Drawing Title:
ELEVATIONS

Drawing No: