

VALLEY CREEK CORPORATE CENTER

Exton, PA
a development of



4100 One Commerce Square
2005 Market Street

WRT Planning & Design

Wallace Roberts & Todd, LLC


260 South Broad Street Philadelphia, PA 19102 215.732.5215 fax 215.732.2551

Consultants:


Mechanical, Electrical, & Plumbing Engineering
McHugh Engineering
550 Pines Hill Road, Suite 205
Fort Washington, PA 19334
Phone: 215-641-1158 Fax: 215-641-0194

Structural Engineering
Cagley, Harman & Associates
1015 West North Avenue
King of Prussia, PA 19406
Phone: 610-337-3360 Fax: 610-337-3359

Specifications
FOCUS Collaborative, Inc.
1280 Stage Coach Road
Palermo, NJ 08230
Phone: 609-390-8281 Fax: 609-390-7504

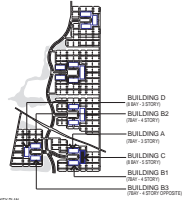

PHASE II BUILDING III BUILDING TYPE C

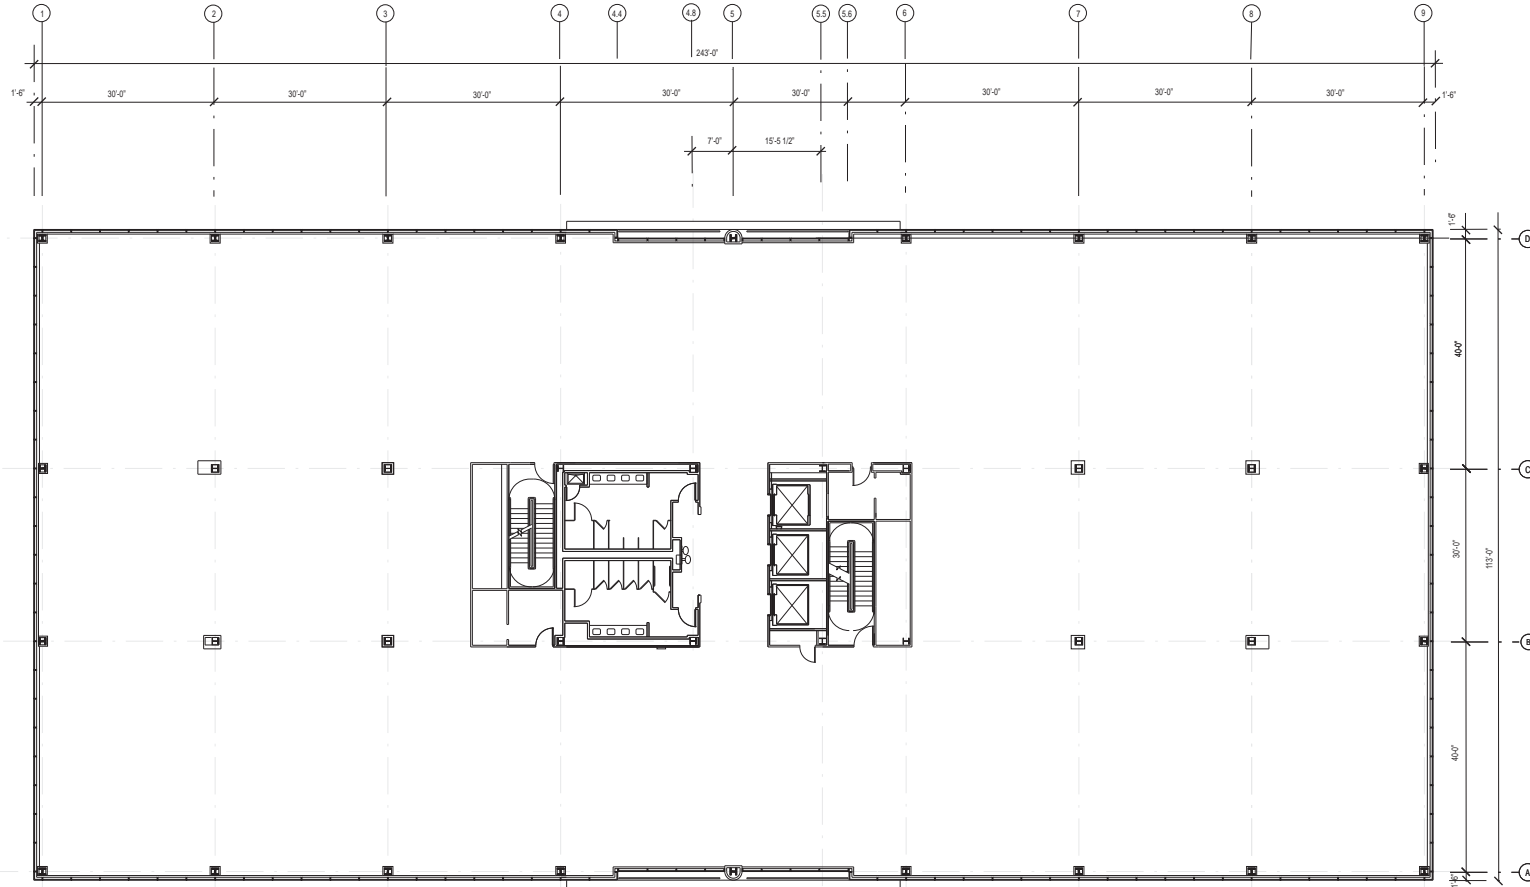

FOURTH FLOOR PLAN

Drawing Title:
FOURTH FLOOR PLAN

Drawing No: