

# VALLEY CREEK CORPORATE CENTER

Exton, PA  
a development of



4100 One Commerce Square  
2005 Market Street

**WRT** Planning & Design

## Wallace Roberts & Todd, LLC

260 South Broad Street Philadelphia, PA 19102 215.732.5215 fax 215.732.2551

Consists:

Mechanical, Electrical, & Plumbing Engineering


McHugh Engineering  
550 Pines Hill Road, Suite 205  
Fort Washington, PA 19034  
Phone: 215-641-1158 Fax: 215-641-0194

Structural Engineering


Cagley, Harman & Associates  
1015 West North Avenue  
King of Prussia, PA 19406  
Phone: 610-337-3360 Fax: 610-337-3359

Specifications

FOCUS Collaborative, Inc.  
1280 Stage Coach Road  
Palermo, NJ 08230  
Phone: 609-390-8281 Fax: 609-390-7504

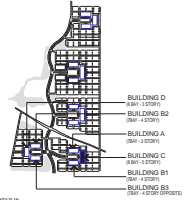

## PHASE II BUILDING III BUILDING TYPE C

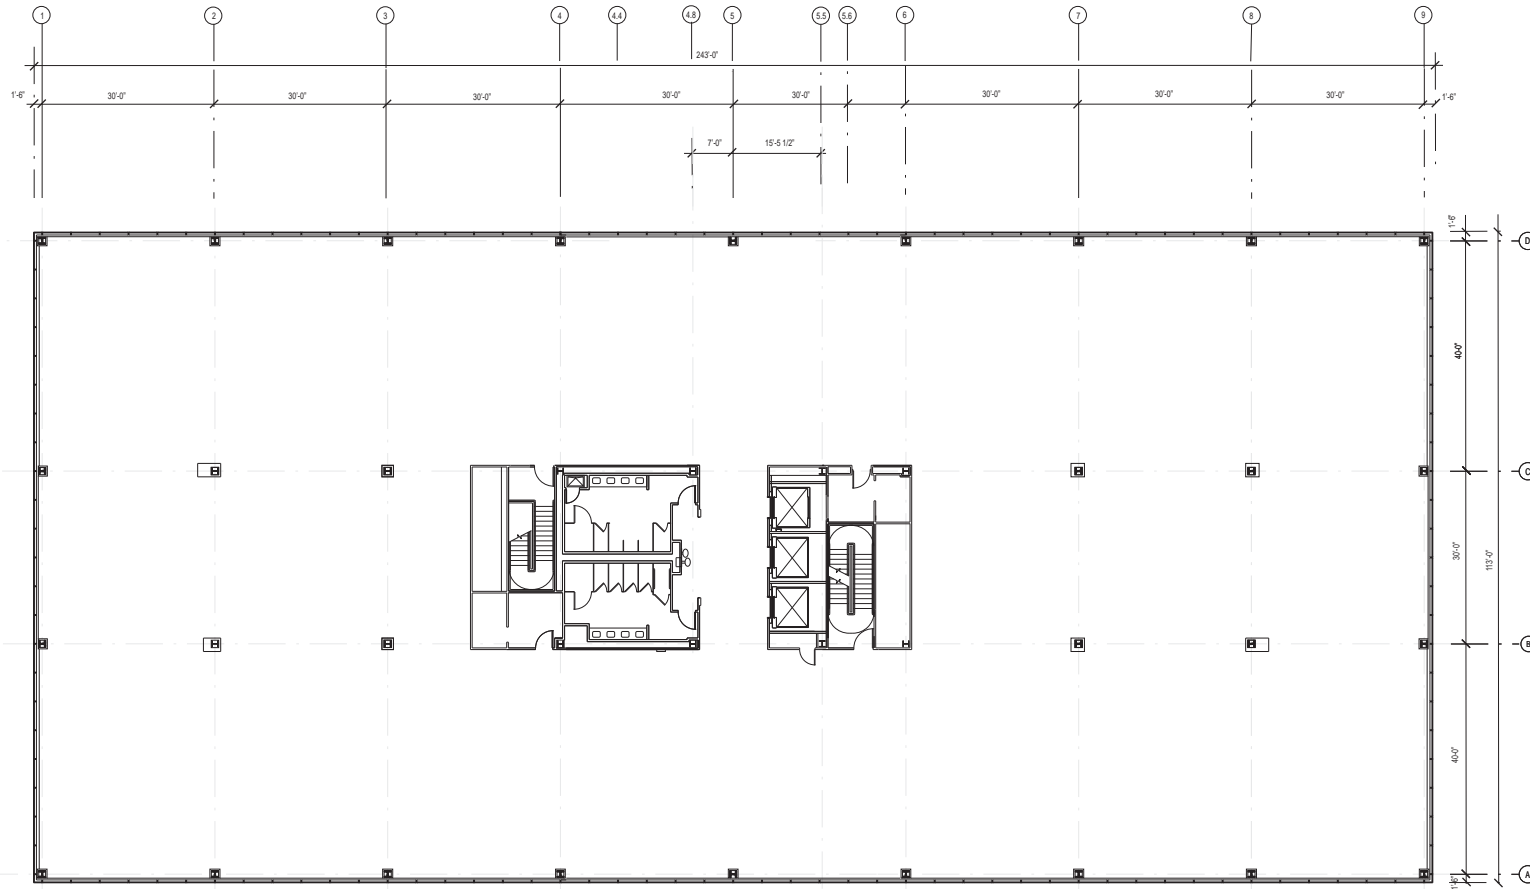

**FIFTH FLOOR PLAN**

Drawing Title:  
**FIFTH FLOOR PLAN**

Drawing No: